


WT 1007 1981

PROJECT	MAURO POWER STATION
CLIENT	THE GOVERNMENT OF THE MARSHALL ISLANDS
MAIN CONTRACTOR	AEE GROSSLEY LTD
PRIME CONTRACTOR	ISECO INTERNATIONAL POWER SYSTEMS LTD 85-87 JERRYN STREET LONDON SW17 6JD
SCALE	AS SHOWN
DRAWN	ENGINE HALL
CHECKED	GROUND FLOOR PLAN
APPROVED	CABLE TRAY ROUTING
TITLE	W.H. SMITH & CO. ELECTRICAL ENGINEERS LTD. DRAWING No WHS/13033
DATE	SHT 1 of 7

- NOTES
- ALL CABLE TRAY DETAILS, SHOWN ON ENGINE NO 1 ARE TYPICAL FOR ENGINES NO 2,3 & 4, RESPECTIVELY.
 - TRAY ARRANGEMENT BELOW 13.8KV & STATION AUXILIARIES SWITCHBOARD TO BE DETERMINED ON SITE.

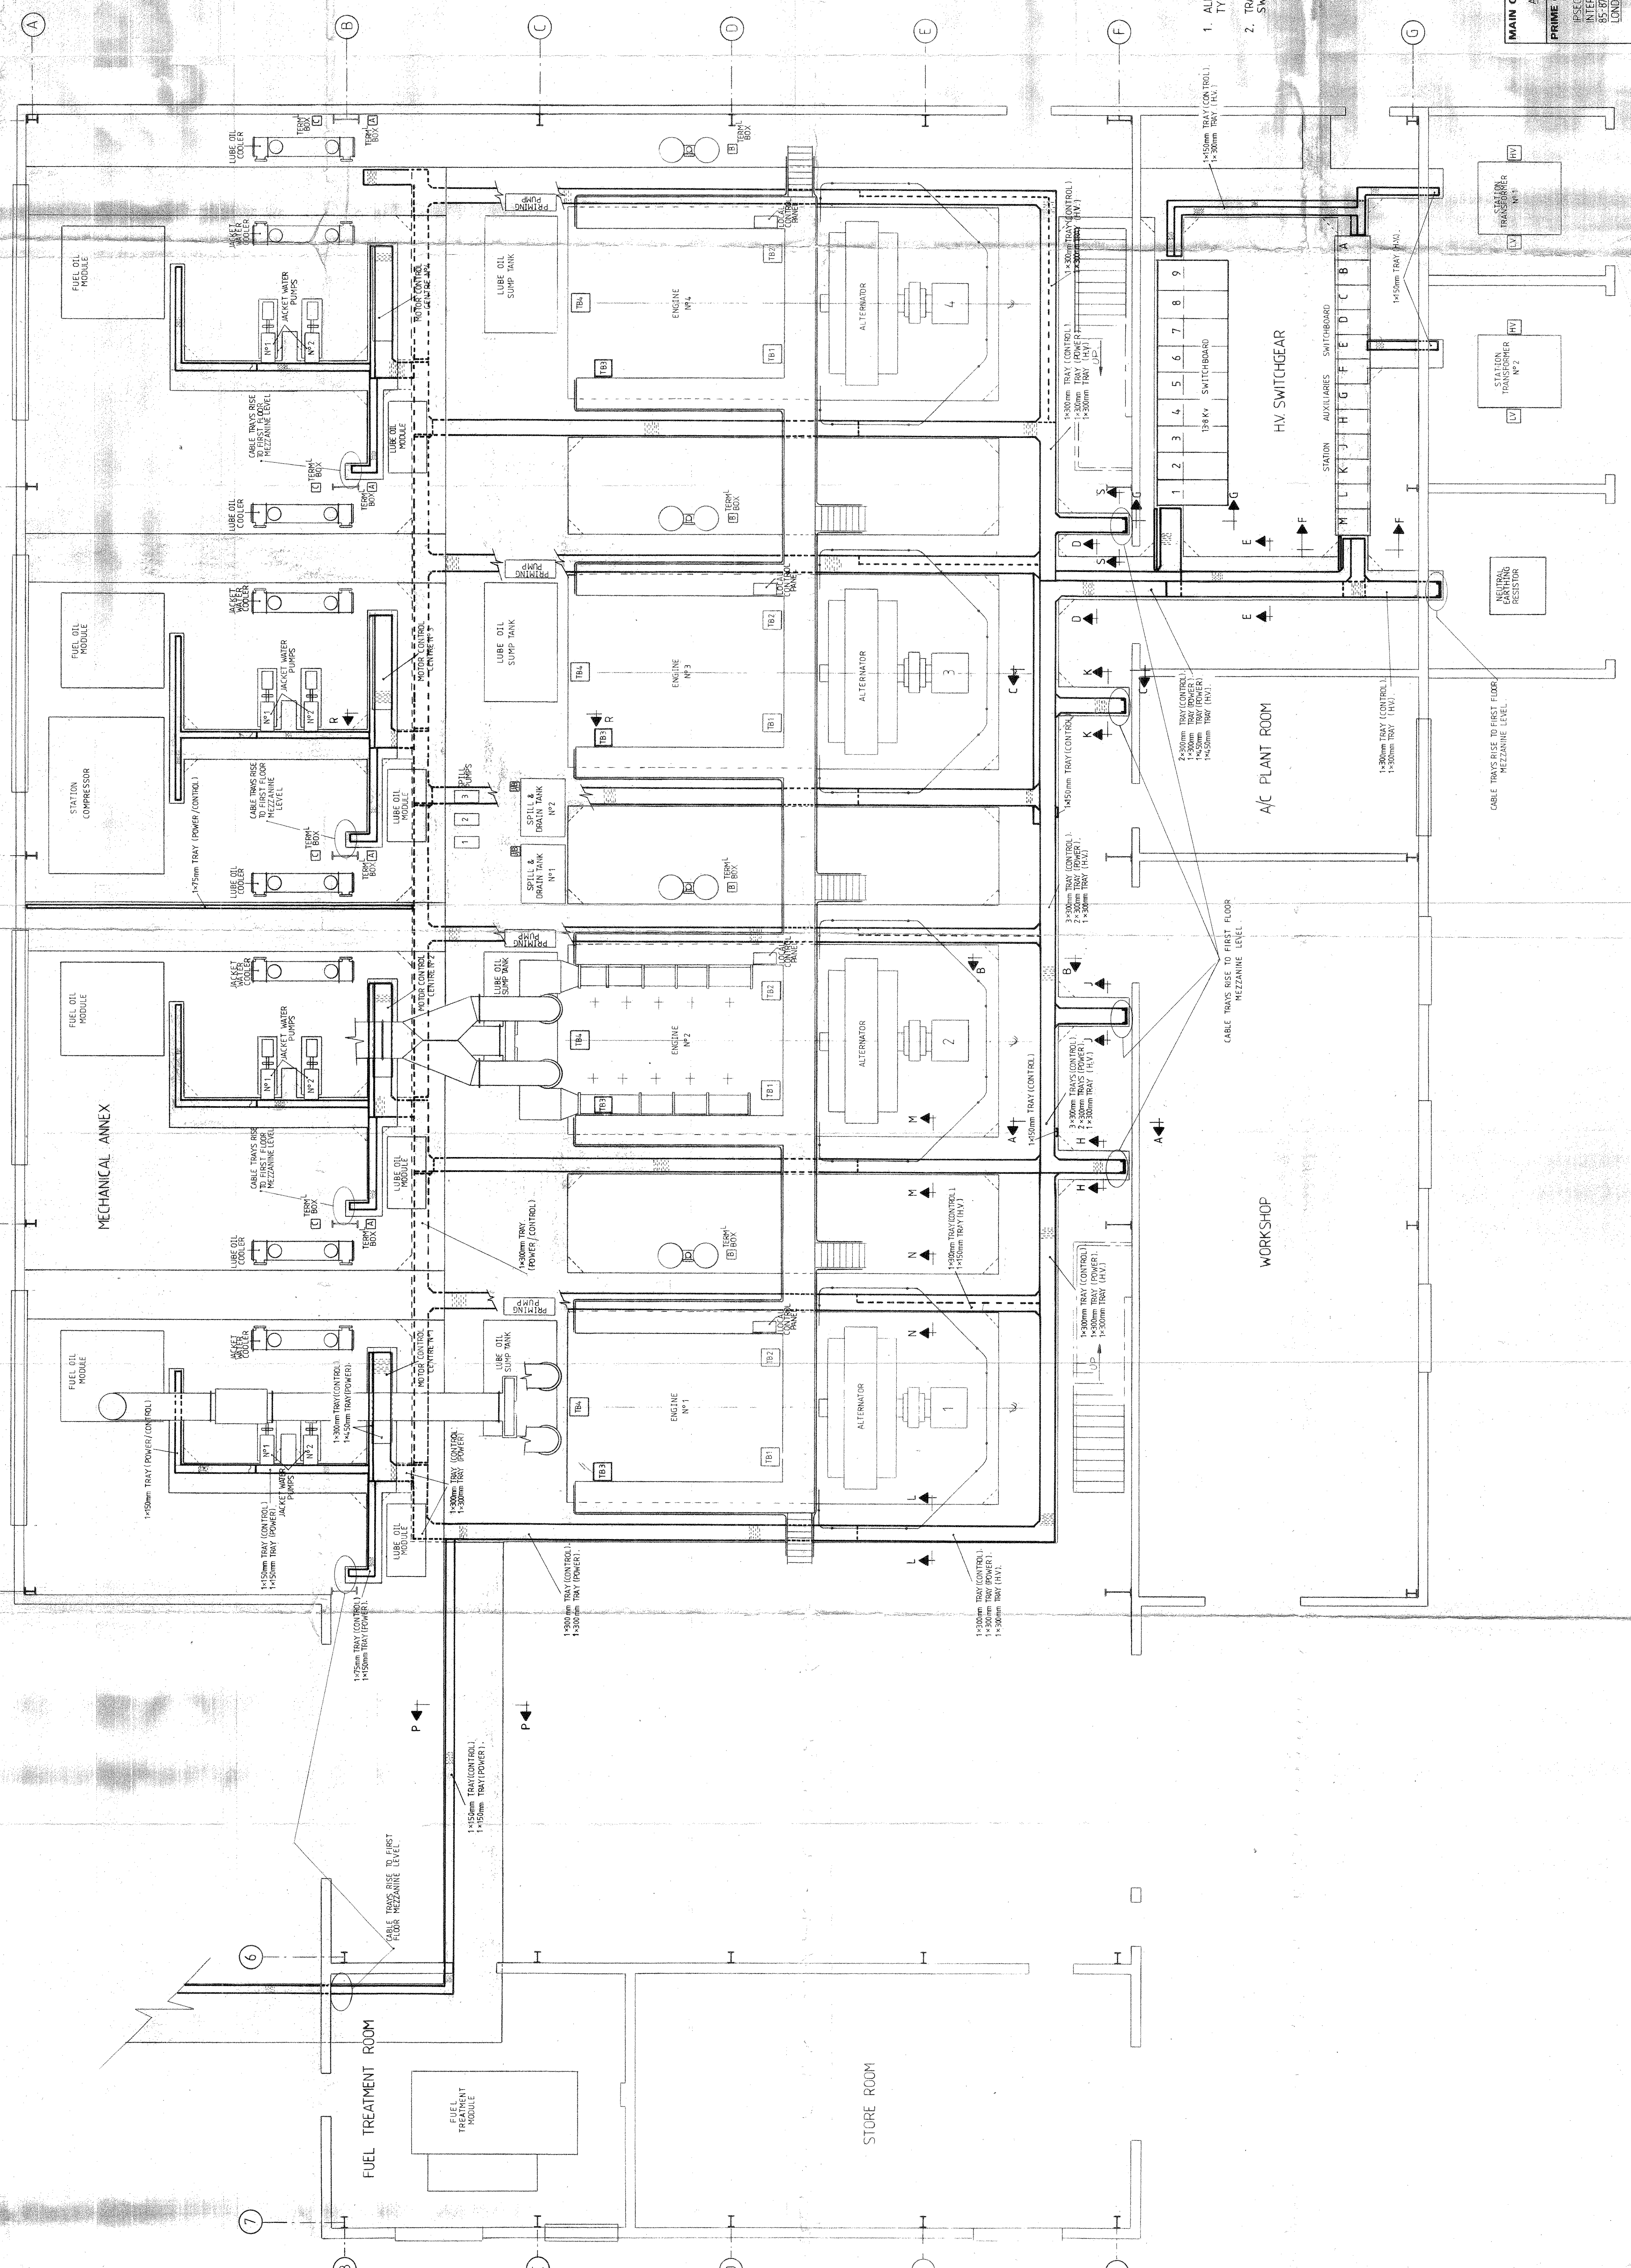

REVISION	DATE	CHECKED